




KEY NOTES

- 1) EXISTING AIR COMPRESSOR TO REMAIN. PROTECT DURING CONSTRUCTION.
- 2) REMOVE EXISTING COMPRESSED AIR PIPING ALONG NORTH WALL BACK TO COMPRESSOR. SEE SHEET P1.0 FOR NEW COMPRESSED AIR PIPING CONSTRUCTION. SEE SHEET P1.0 FOR NEW LOCATION.
- 3) DISCONNECT EXISTING LUBE EQUIPMENT. KEEP PROTECTED DURING CONSTRUCTION. SEE SHEET P1.0 FOR NEW LOCATION.
- 4) GAS PIPING ATTACHED TO CEILING ALONG THIS WALL TO REMAIN AND BE FULLY FUNCTIONAL.
- 5) REMOVE GAS PIPING FROM CEILING TO BELOW GROUND TO BEYOND WHERE NEW FOUNDATION WILL BE POURED. SEE SHEET P1.0 FOR NEW GAS PIPING. SEE AND ALTERNATE #?
- 6) EXISTING PLUMBING IN THIS ROOM SHALL REMAIN AND BE FULLY FUNCTIONAL. SEE AND ALTERNATE #?
- 7) EXISTING BRINKING FOUNTAIN AND EXTENSION TO REMAIN AND BE FULLY FUNCTIONAL. PROTECT DURING CONSTRUCTION.
- 8) REMOVE THE EXISTING WASTE PIPING FROM THE 2 SAND/OIL SEPARATORS THAT ARE BETWEEN BAYS 12 AND 23 TO OUTSIDE THE BUILDING BEFORE WHERE THE NEW FOUNDATION WILL BE POURED.
- 9) EXISTING SAND/OIL SEPARATOR TO REMAIN AND BE FULLY FUNCTIONAL. CONNECT EXISTING WASTE LINE FROM THIS UNIT TO NEW WASTE LINE INTO BUILDING. FIELD VERIFY EXACT LOCATION. SEE AND ALTERNATE #?
- 10) RESTROOM FIXTURES TO REMAIN AND BE FULLY FUNCTIONAL. SEE AND ALTERNATE #?
- 11)

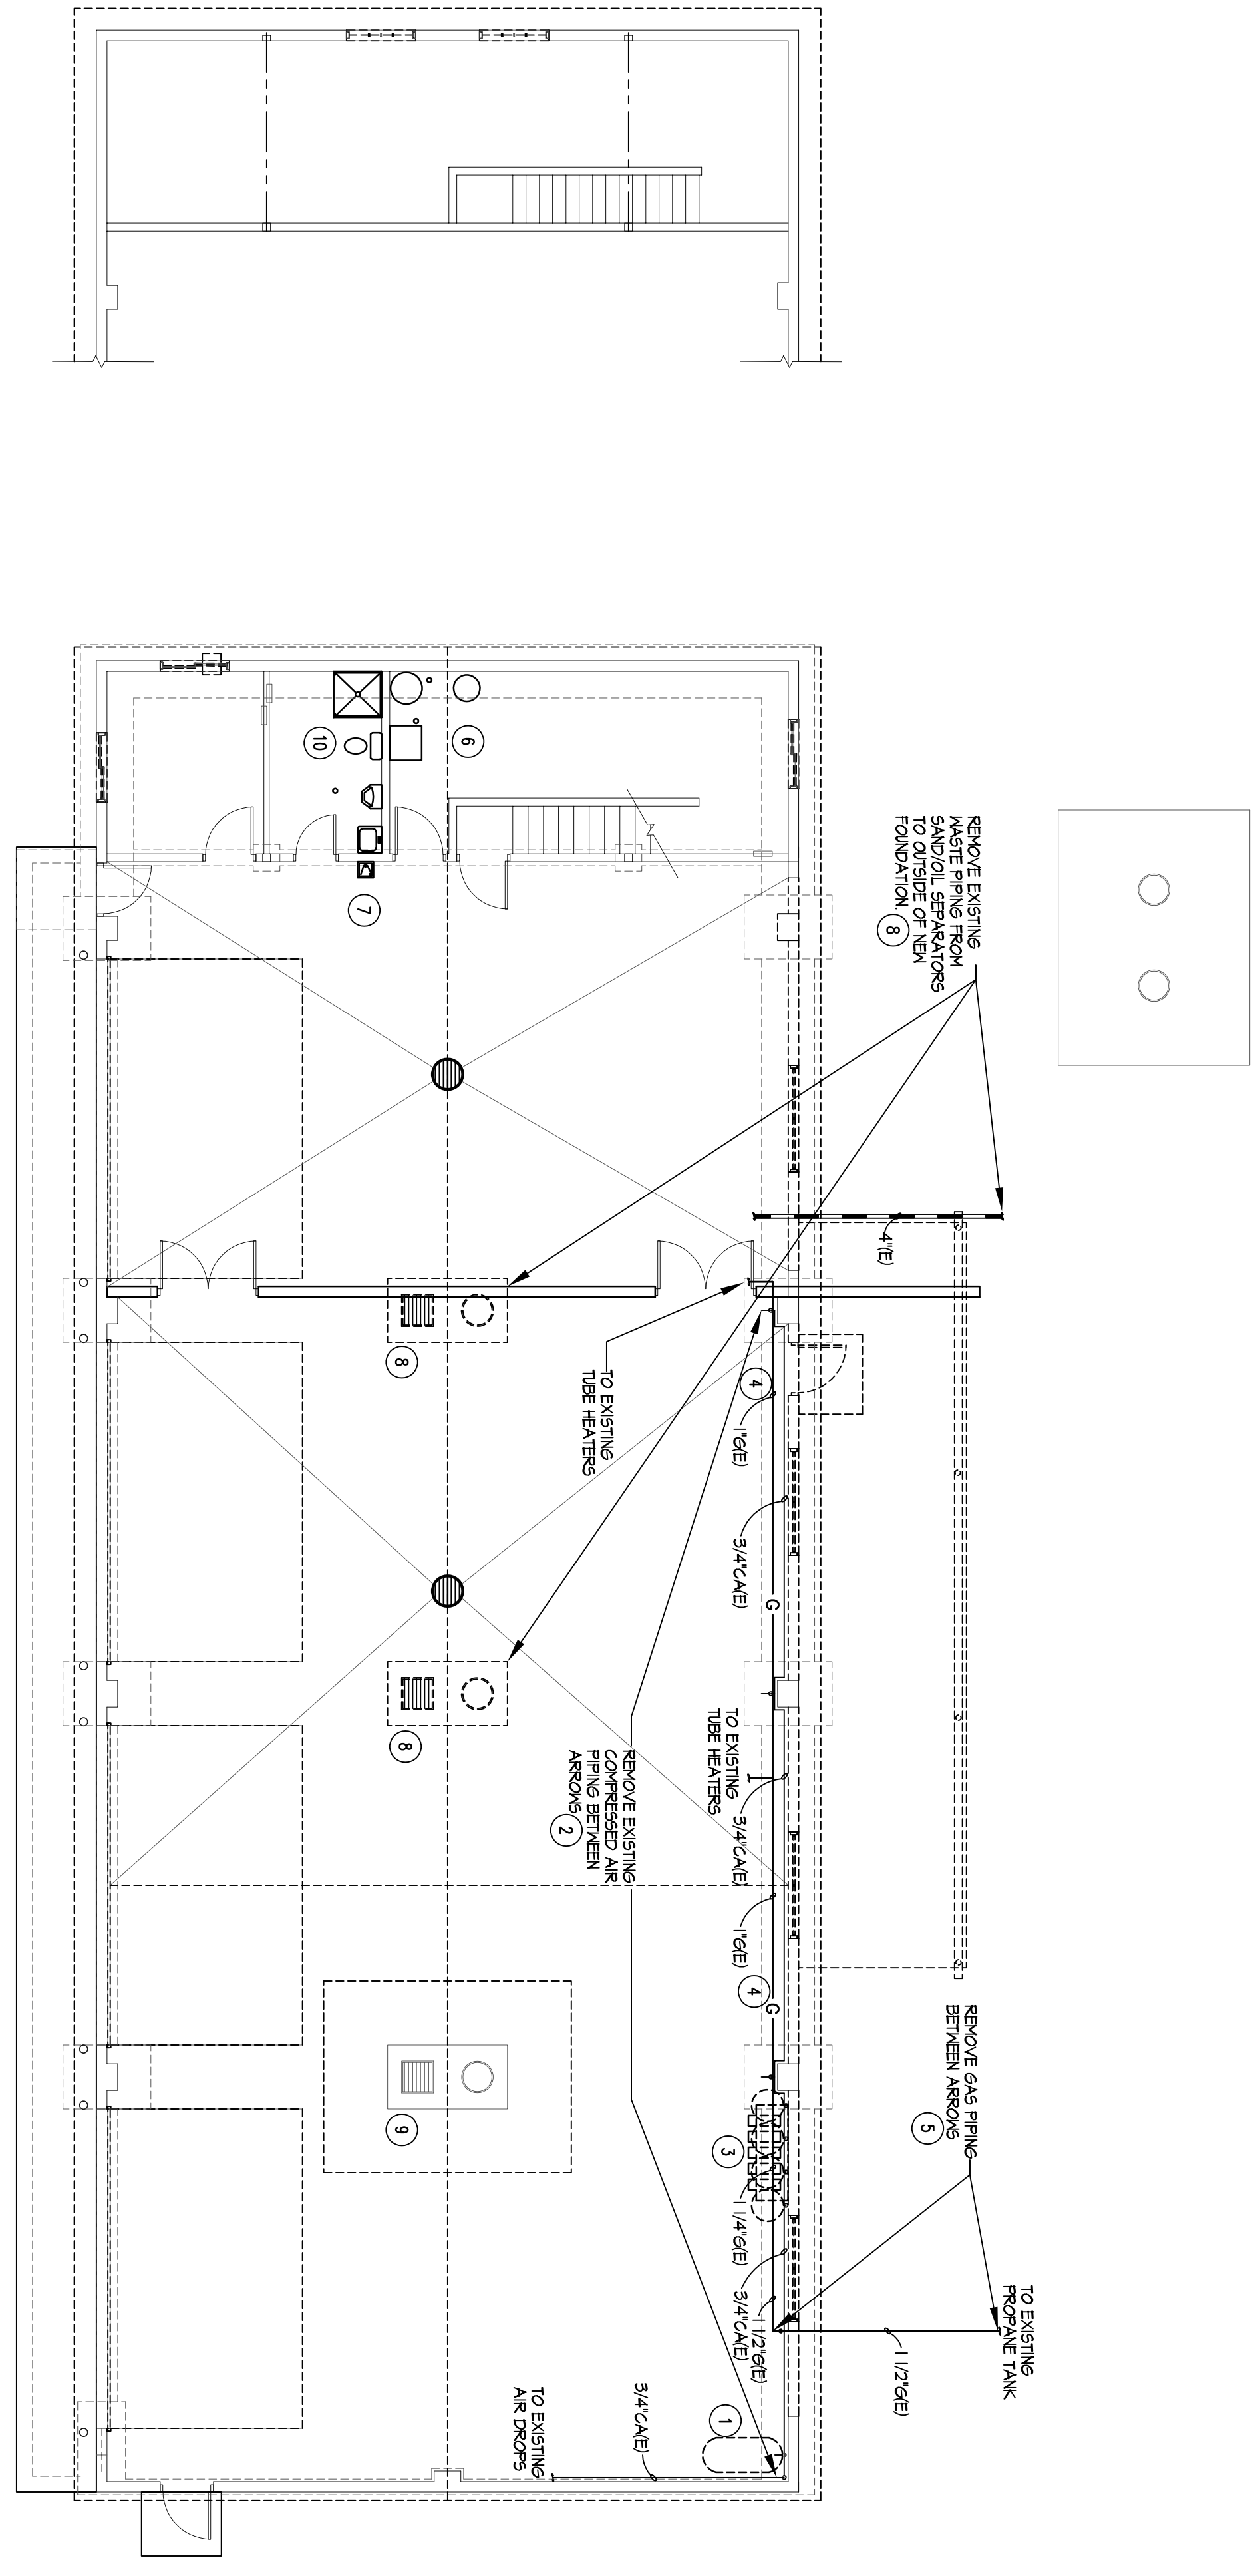

FLOOR PLAN - PLUMBING DEMOLITION

SCALE: 1/8" = 1'-0"

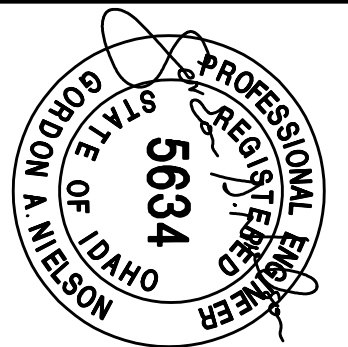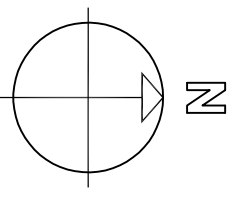

HSM HUTCHISON SMITH ARCHITECTS
 270 North 27th St. Boise, Idaho. 83702 (208) 338-1212 fax (208) 338-0011

PROJECT: 1820
 FILE:
 DATE: MARCH 2018
 DRAWN: SVB
 REVISIONS:

CAREY MAINTENANCE BUILDING ADDITION
IDAHO TRANSPORTATION DEPARTMENT
 N. MAIN ST / US HWY 26 CAREY, IDAHO 83320

P0.5
 SHEET NO.
 IDAHO DEPARTMENT OF RECREATION

G:\LOCAL\Aberdeen VoAg Multi-Purpose - 1631\MECH\ABERDEEN VoAg-M2.0.dwg January 06 2017 10:34am By:Scott